

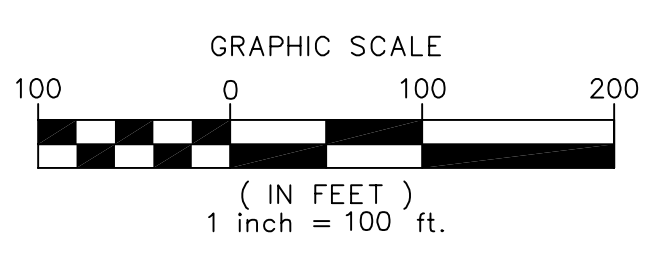


NOTE  
SEE CIC-C-17-PFS-151967-1 FOR KEY PLAN AND GENERAL NOTES.

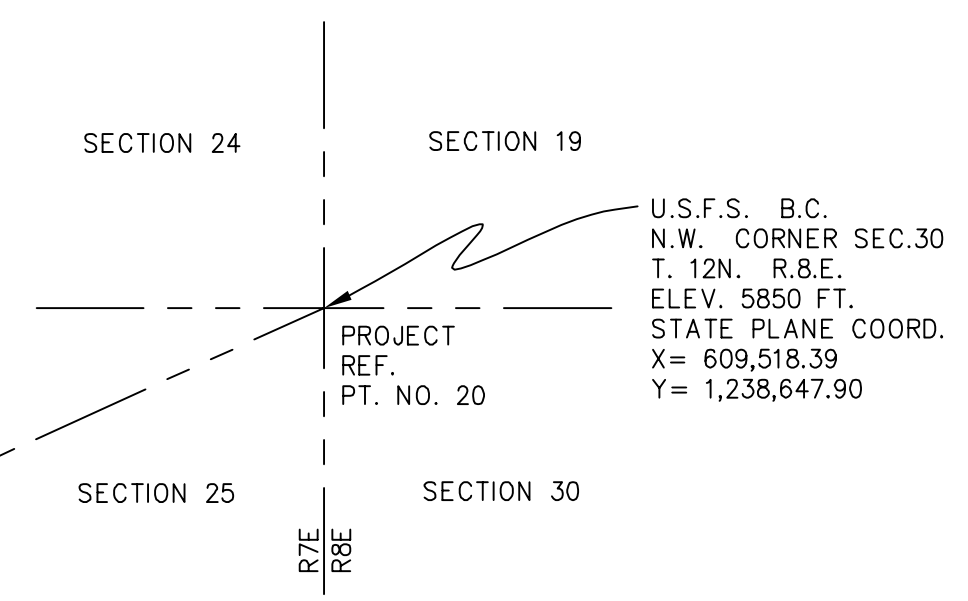

3	3-10-06	As-Built Conditions	CRS	MLD		JDM	58-9902
2	1-7-05	Remove remaining housing per USFS	PRATT	PSS		JDM	58-9902
1	11-3-04	GENERAL REVISION	AN	PSS		JDM	9902

CHILDS - IRVING HYDROELECTRIC PROJECT  
DECOMMISSIONING  
CHILDS POWER PLANT  
REMOVAL PLAN

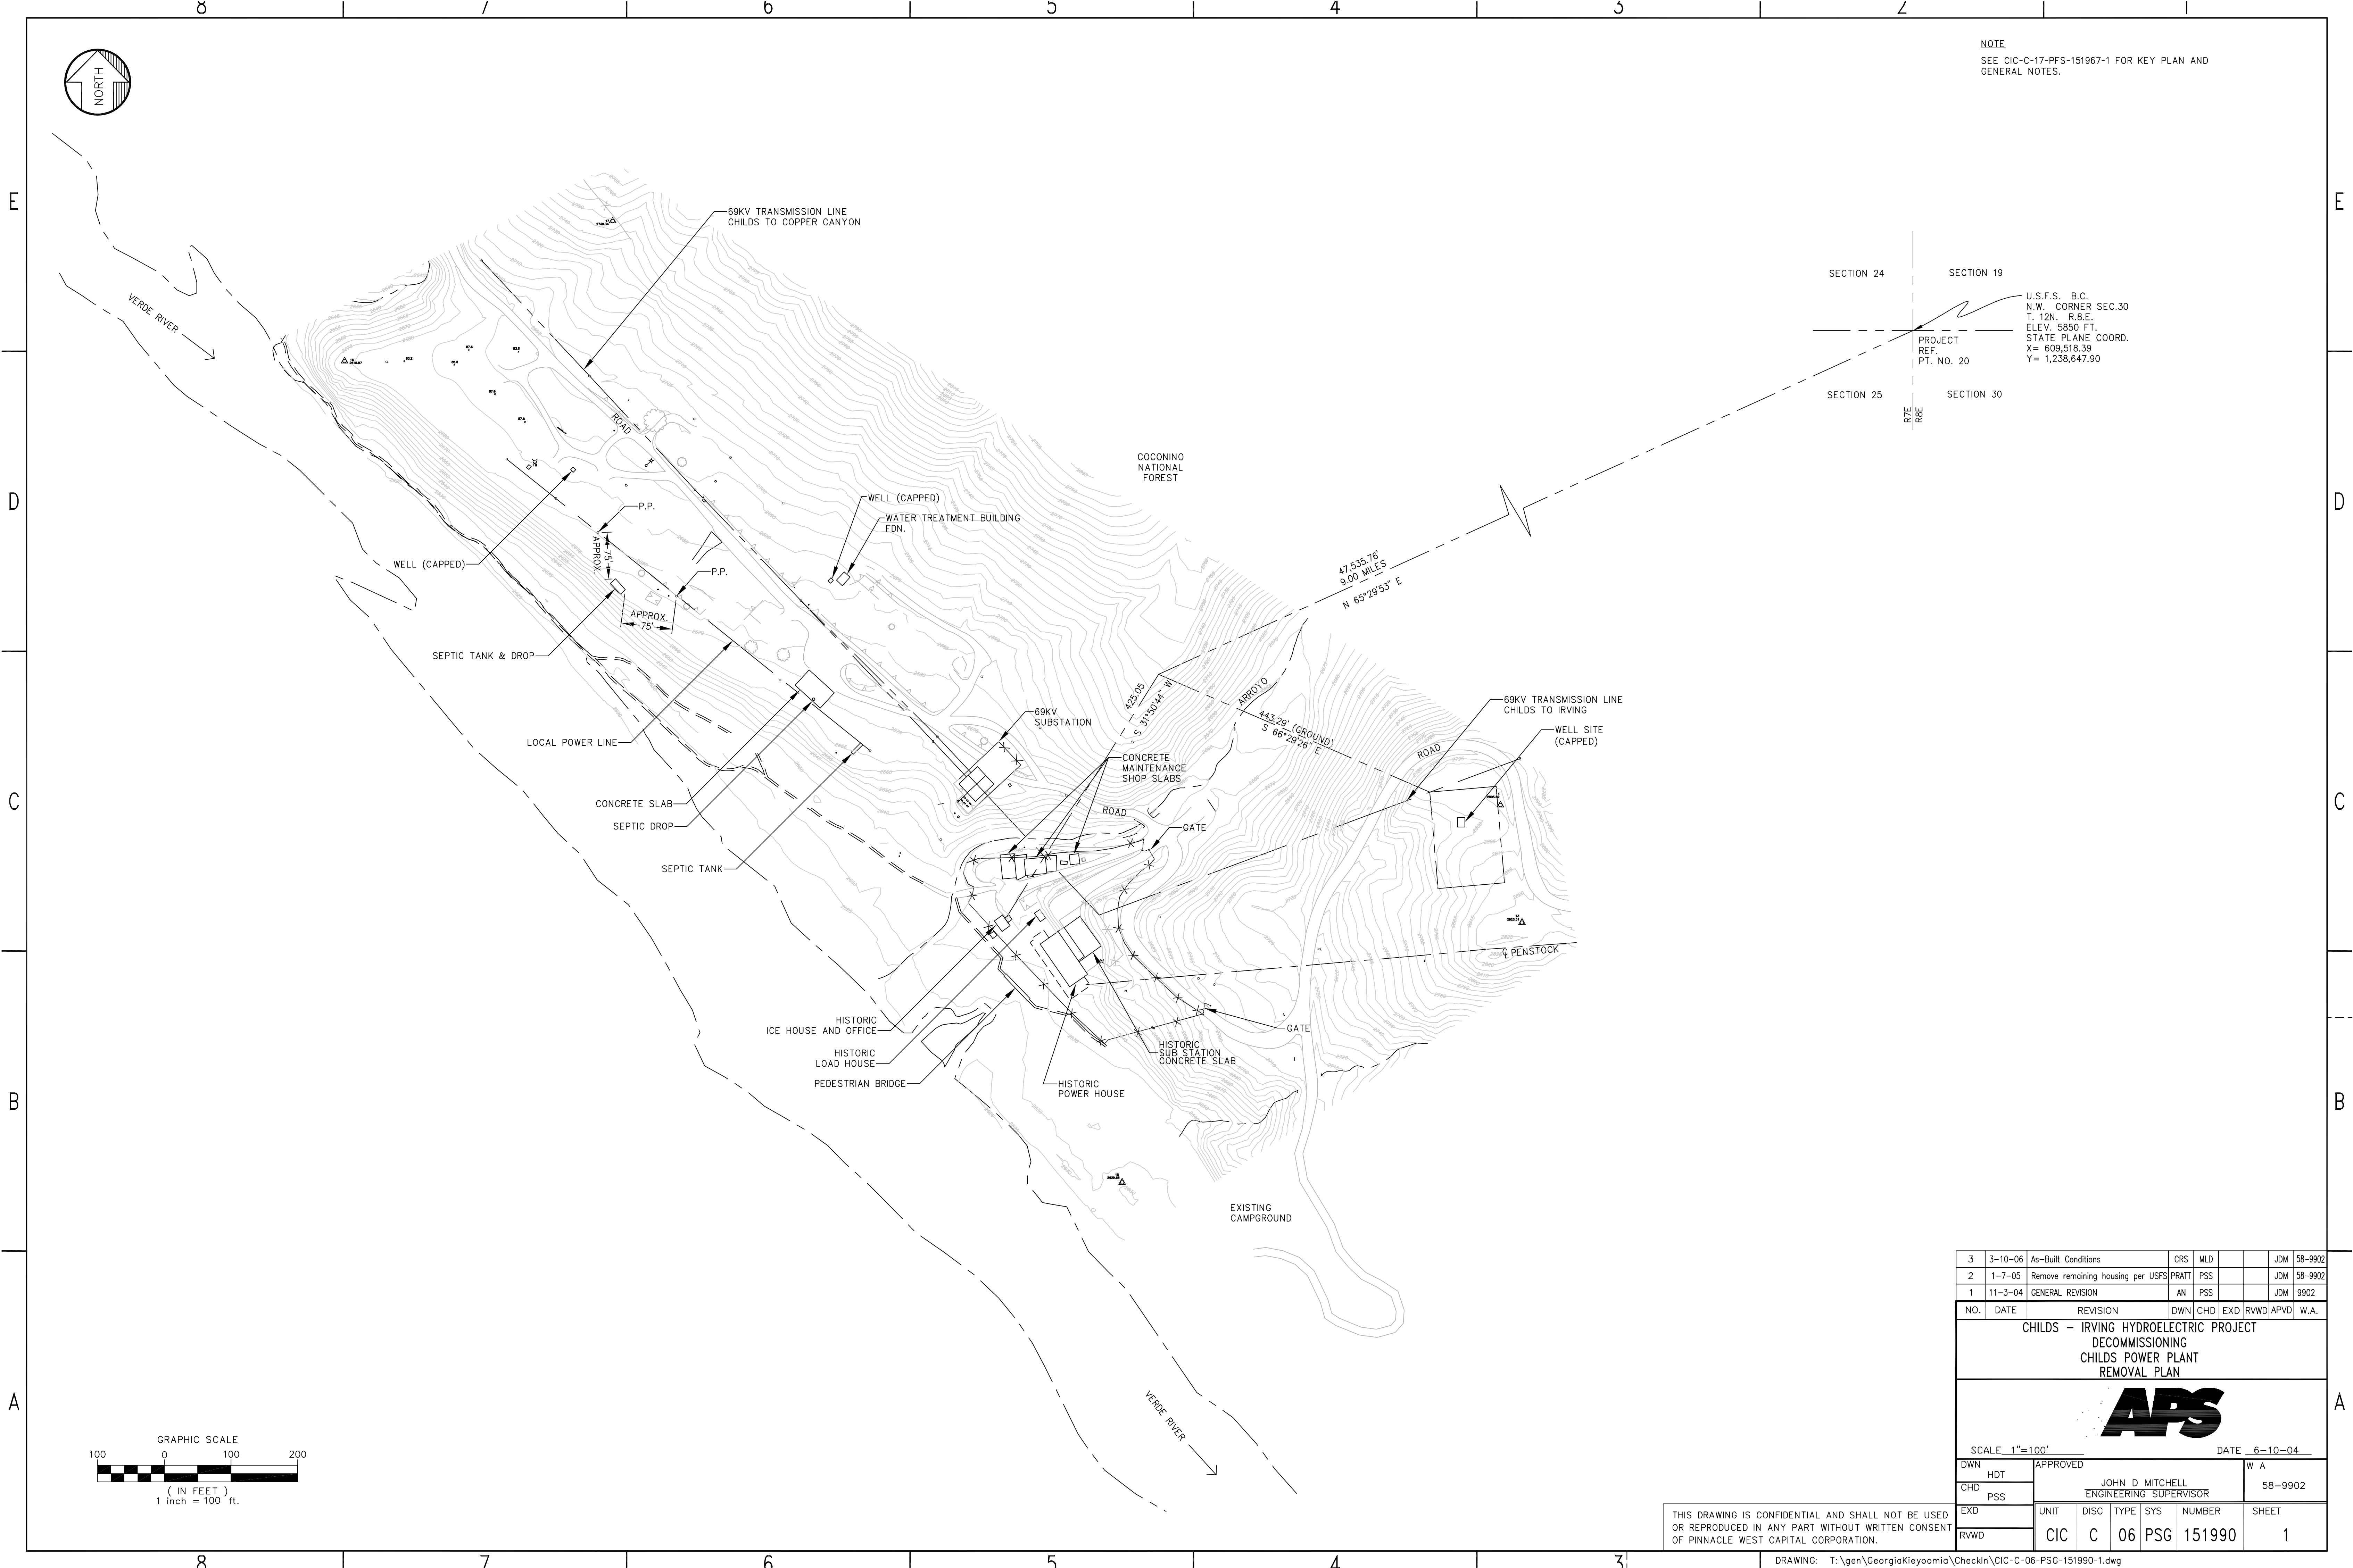

SCALE 1"=100'		DATE 6-10-04	
DWN	HDT	APPROVED	W A
CHD	PSS	JOHN D MITCHELL ENGINEERING SUPERVISOR	58-9902

EXD	UNIT	DISC	TYPE	SYS	NUMBER	SHEET
RWVD	CIC	C	06	PSG	151990	1

THIS DRAWING IS CONFIDENTIAL AND SHALL NOT BE USED OR REPRODUCED IN ANY PART WITHOUT WRITTEN CONSENT OF PINNACLE WEST CAPITAL CORPORATION.